


DUPLICATE

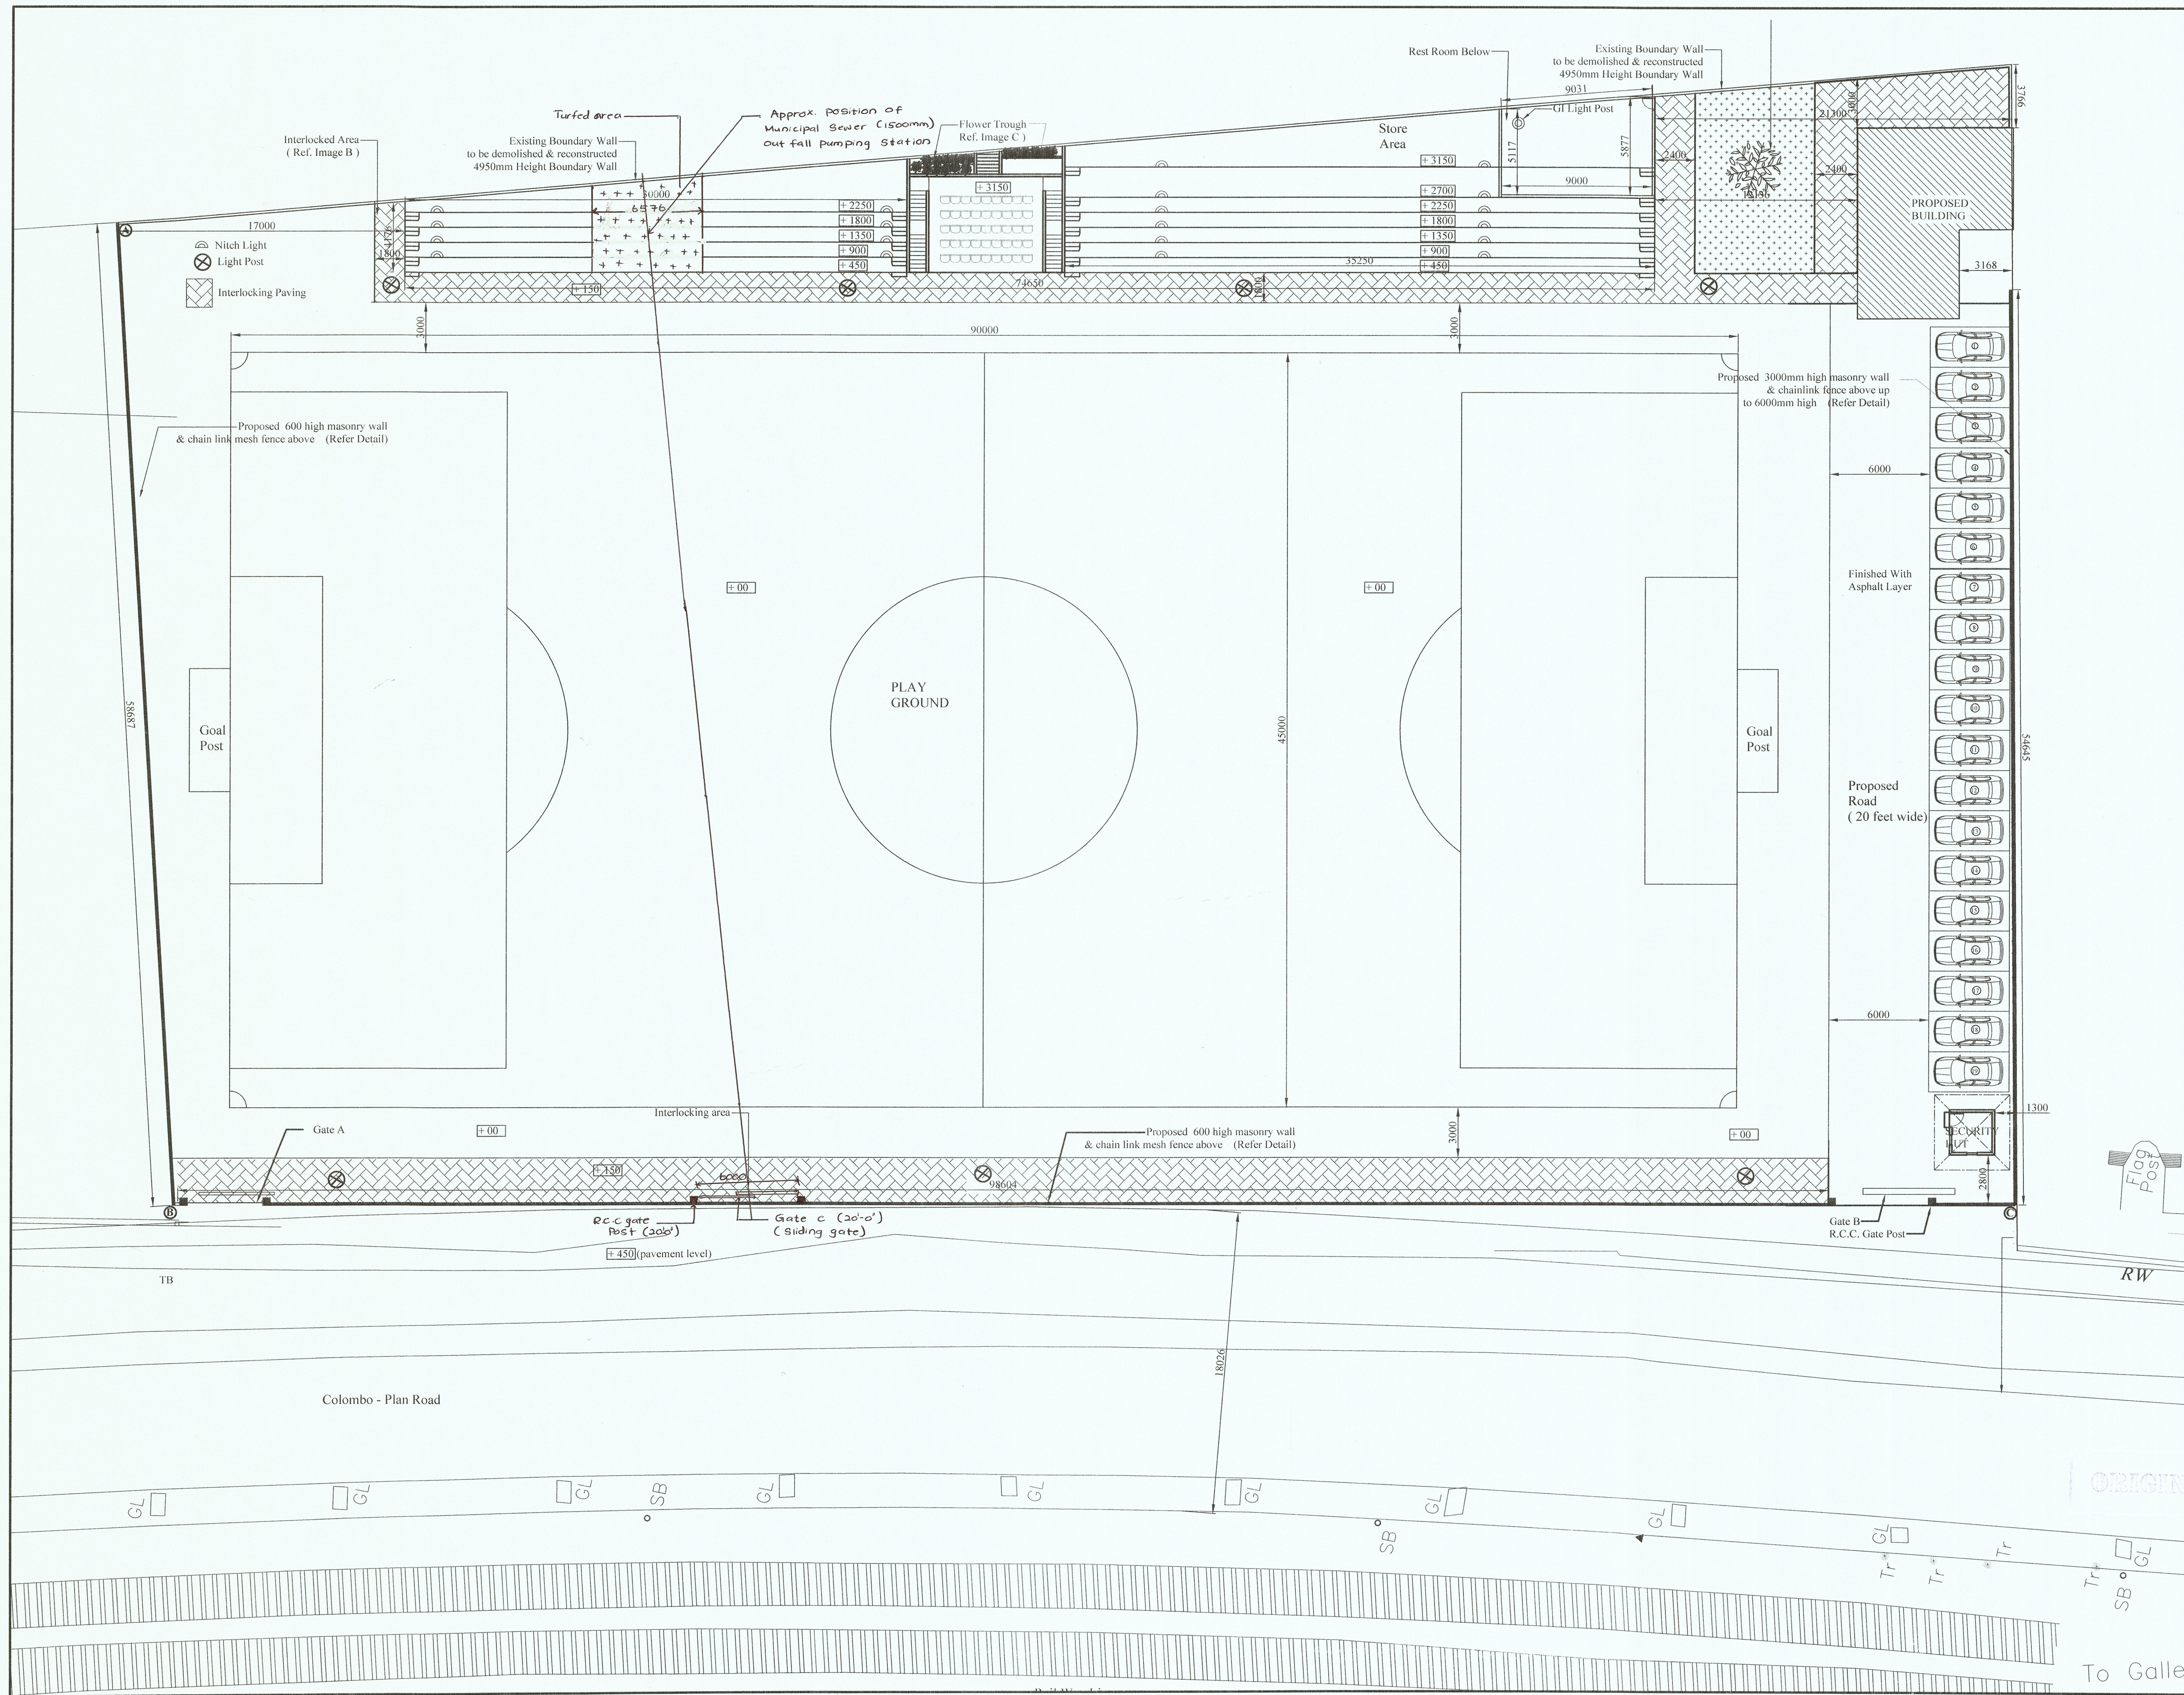

- NOTE**
01. This drawing is a property of the Architectural unit of the M.E's Department.
 02. This drawing shall not be copied or altered without the consent of the Architect.
 03. If any discrepancy or error is detected in the drawing it should be immediately notice of the Architect.
 04. This drawing should be read in conjunction with structural drawings & all service drawings and any other drawings referred to in here.
 05. Any construction work carried out not in accordance with the information in the drawing will be rejected by the Architect.
 06. All dimensions to be checked at site prior to the construction.
 07. Colours of fittings & tiles to be approved by the Architect.
 08. Existing Building to be demolished with the approval of relevant authorities.
 09. Ground to be turfed with necessary ground preparations.
 10. Surface water drainage and Suitable Sprinkler System to be Engineer's details.
 11. Lighting layout to Electrical Engineer's Details.

ALL NECESSARY APPROVALS TO BE OBTAINED PRIOR TO TENDER PROCEDURE AND COMMENCEMENT OF CONSTRUCTION.

COLOMBO MUNICIPAL COUNCIL MUNICIPAL ENGINEER'S DEPARTMENT			
Job title PROPOSED RUDRA PLAY GROUND COMPLEX AT MARINE DRIVE, COLOMBO 06. (PLAY GROUND)			
Drawing title SITE PLAN & LANDSCAPING DESIGN			
PROJECT ARCHITECT	UTHIPALA PALIHAWADANA		
SENIOR ARCHITECT	SURUDOLAPHILLA		
CHIEF ARCHITECT	M.C.L.FERNANDO		
DIRECTOR (Eng./ TDRS)	P.A.CHANDRAPALA		
D.M.C.(Eng.services.)	Y.S.VIJAYAKRISHNAN		
SCALE	DRAWN	CHECKED	
1:200	KAVINDU	Chavinda Senarathne	
JOB NO.	SHEET NO.	D.O.A. ACT:	
2021/09	01/06	Chavinda Senarathne	
CLIENT DEPT./AUTHORIZED OFFICER'S NAME		REVISION SUFFIX	
CLIENT SIGNATURE		DATE : 20-05-2021	
D. Mashanka H. Liyanage (SLAB) Director (Acting) Sports and Recreation Department Colombo Municipal Council		20/05/2021	