


ORIGINAL

The clearance is Granted on the condition that if there are underground sewage and storm water drainage pipe lines expose during the course of excavation within the premises you are liable to stop the work and Inform water Supply and drainage division of CMC immediately. otherwise CMC would take legal action against It.

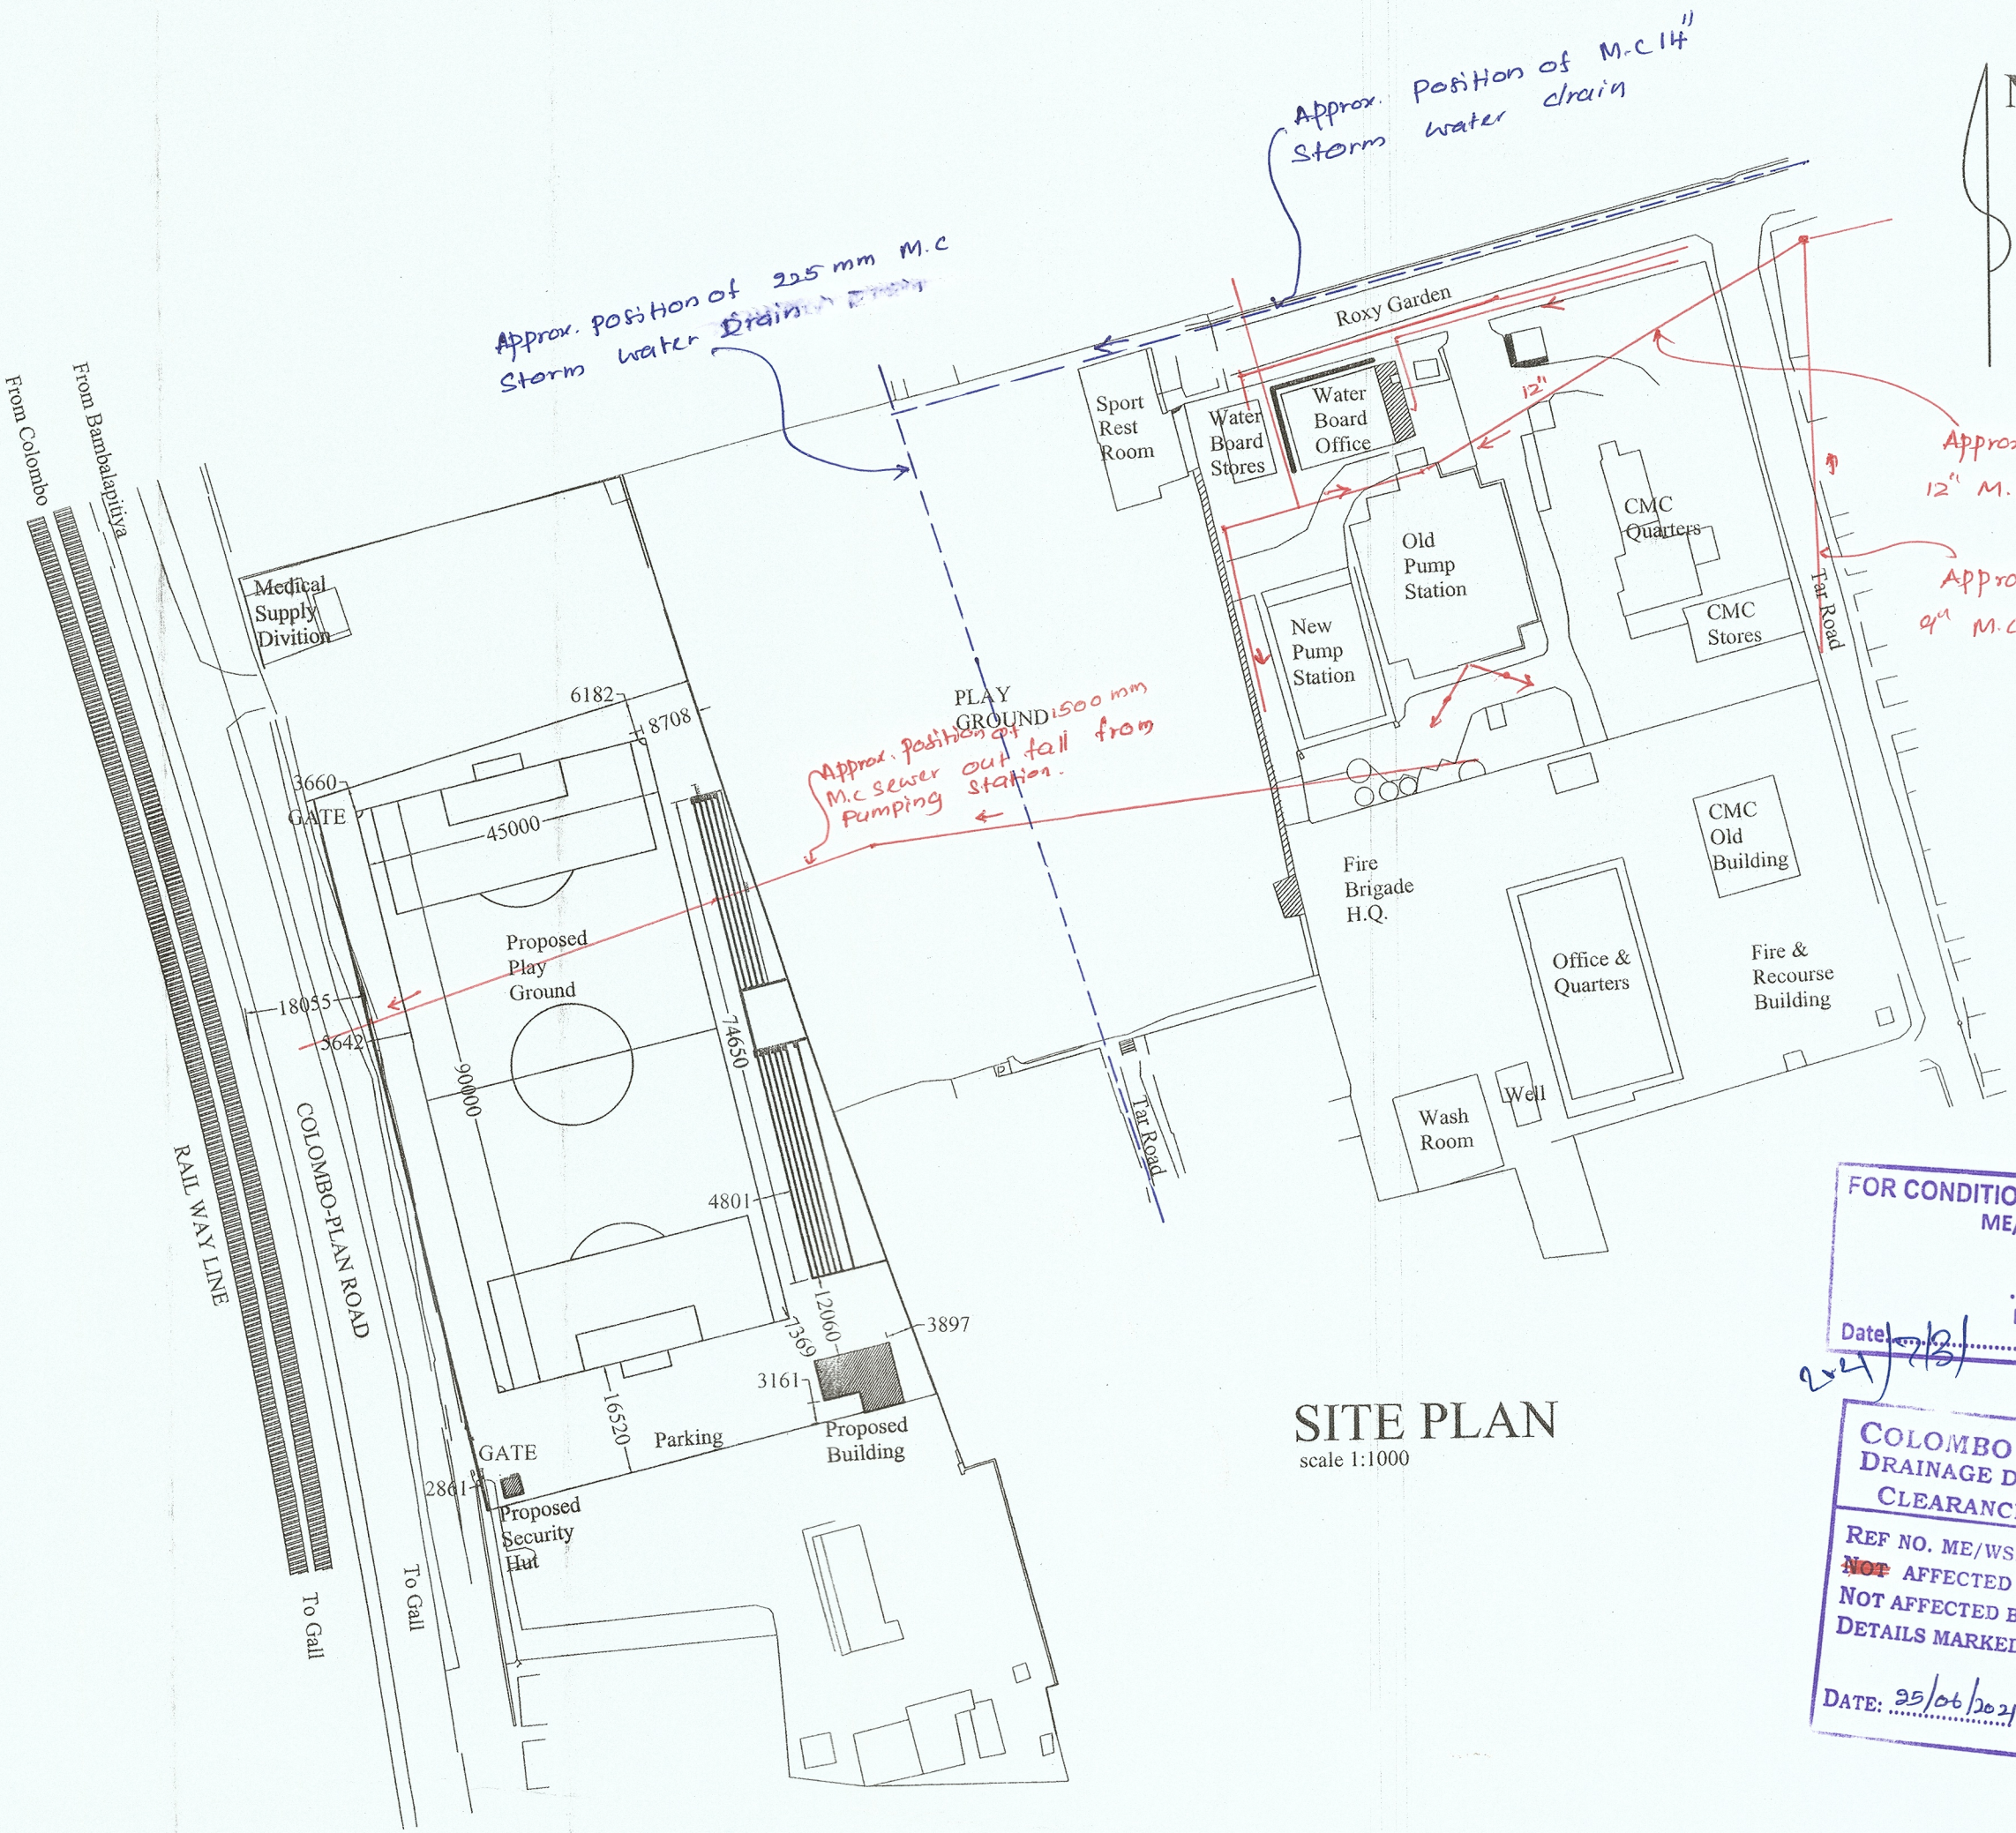

SITE PLAN
scale 1:1000

FOR CONDITION SEE LETTER ATTACHED
ME/WSD/DR/M/CC/319/2021
Date: 25/06/2021
For Deputy Municipal Commissioner
(Engineering Service)

COLOMBO MUNICIPAL COUNCIL
DRAINAGE DIVISION - MALIGAKANDA
CLEARANCE FOR BUILDING PLAN
REF NO. ME/WSD/DR/M/CC/319/2021
NOT AFFECTED BY C.M.C. SEWER/RWD
NOT AFFECTED BY PRIVATE SEWER / RWD
DETAILS MARKED ON BUILDING PLAN
DATE: 25/06/2021 FOR DIRECTOR ENGINEERING
(DRAINAGE)

NOTE :-

- 01.This drawing is a property of the Architectural unit of the M.E's Department.
- 02.This drawing shall not be copied or altered without the consent of the Architect.
- 03.If any discrepancy or error is detected in the drawing it should be immediately notice of the Architect.
- 04.This drawing should be read in conjunction with structural drawings & all service drawings and any other drawings referred to in here.
- 05.Any construction work carried out not in accordance with the information in the drawing will be rejected by the Architect.
- 06.All dimensions to be checked at site prior to the construction.

ALL NECESSARY APPROVALS TO BE OBTAINED PRIOR TO TENDER PROCEDURE AND COMMENCEMENT OF CONSTRUCTION.

COLOMBO MUNICIPAL COUNCIL
MUNICIPAL ENGINEER'S DEPARTMENT

Job title
**PROPOSED RUDRA PLAY GROUND
COMPLEX AT MARINE DRIVE,
COLOMBO 06.
(SECURITY HUT)**

Drawing title

SITE PLAN

PROJECT ARCHITECT	UTHPALA PALIHAWADANA	
STRUCTURAL ENGINEER	K.A.A.S.KULASOORIYA	
SENIOR ARCHITECT	S.U.B.DOLAPHILLA	
DIRECTOR (Eng./ TDRS)	P.A.CHANDRAPALA	
D.M.C.(Eng.services.)	Y.SYLVESTER	
SCALE	DRAWN	CHECKED
1:1000	KAVINDU	Chavindu Senarathne
JOB NO.	SHEET NO.	D.O.A. ACT:
2021/09	03/06	Chavindu Senarathne
CLIENT DEPT/AUTHORIZED OFFICER'S NAME		REVISION SUFFIX
CLIENT SIGNATURE		DATE : -05-2021
DESIGNATION		DATE