

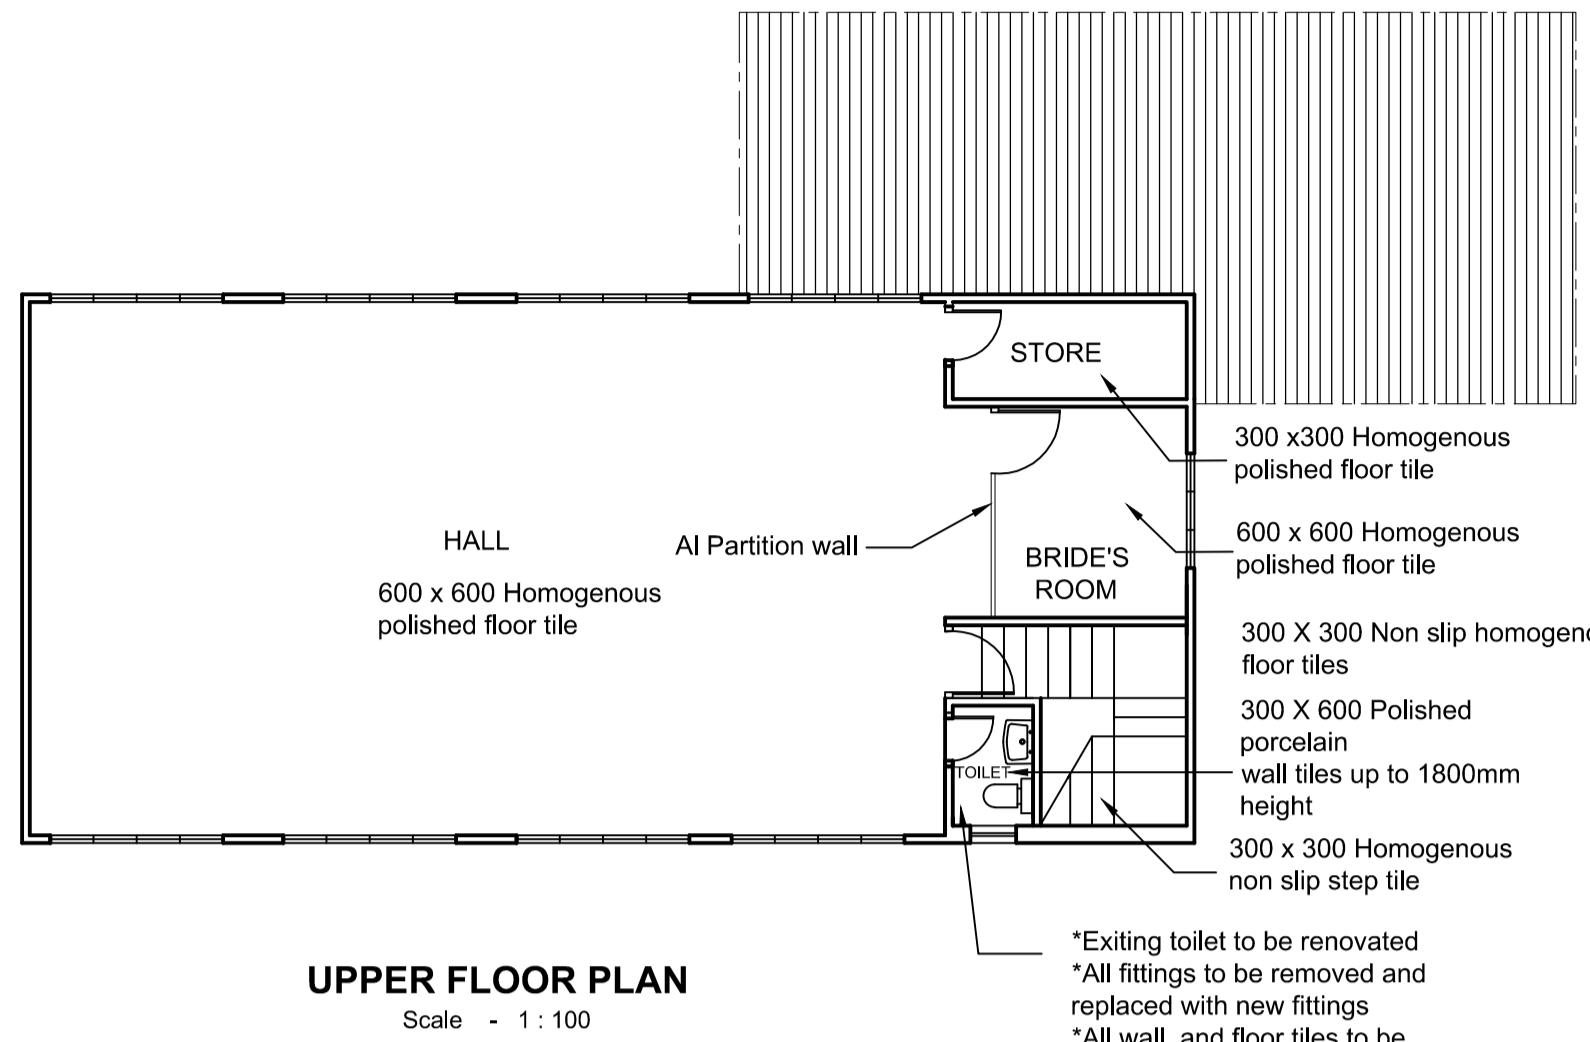


**SPECIFICATION LAYOUT**

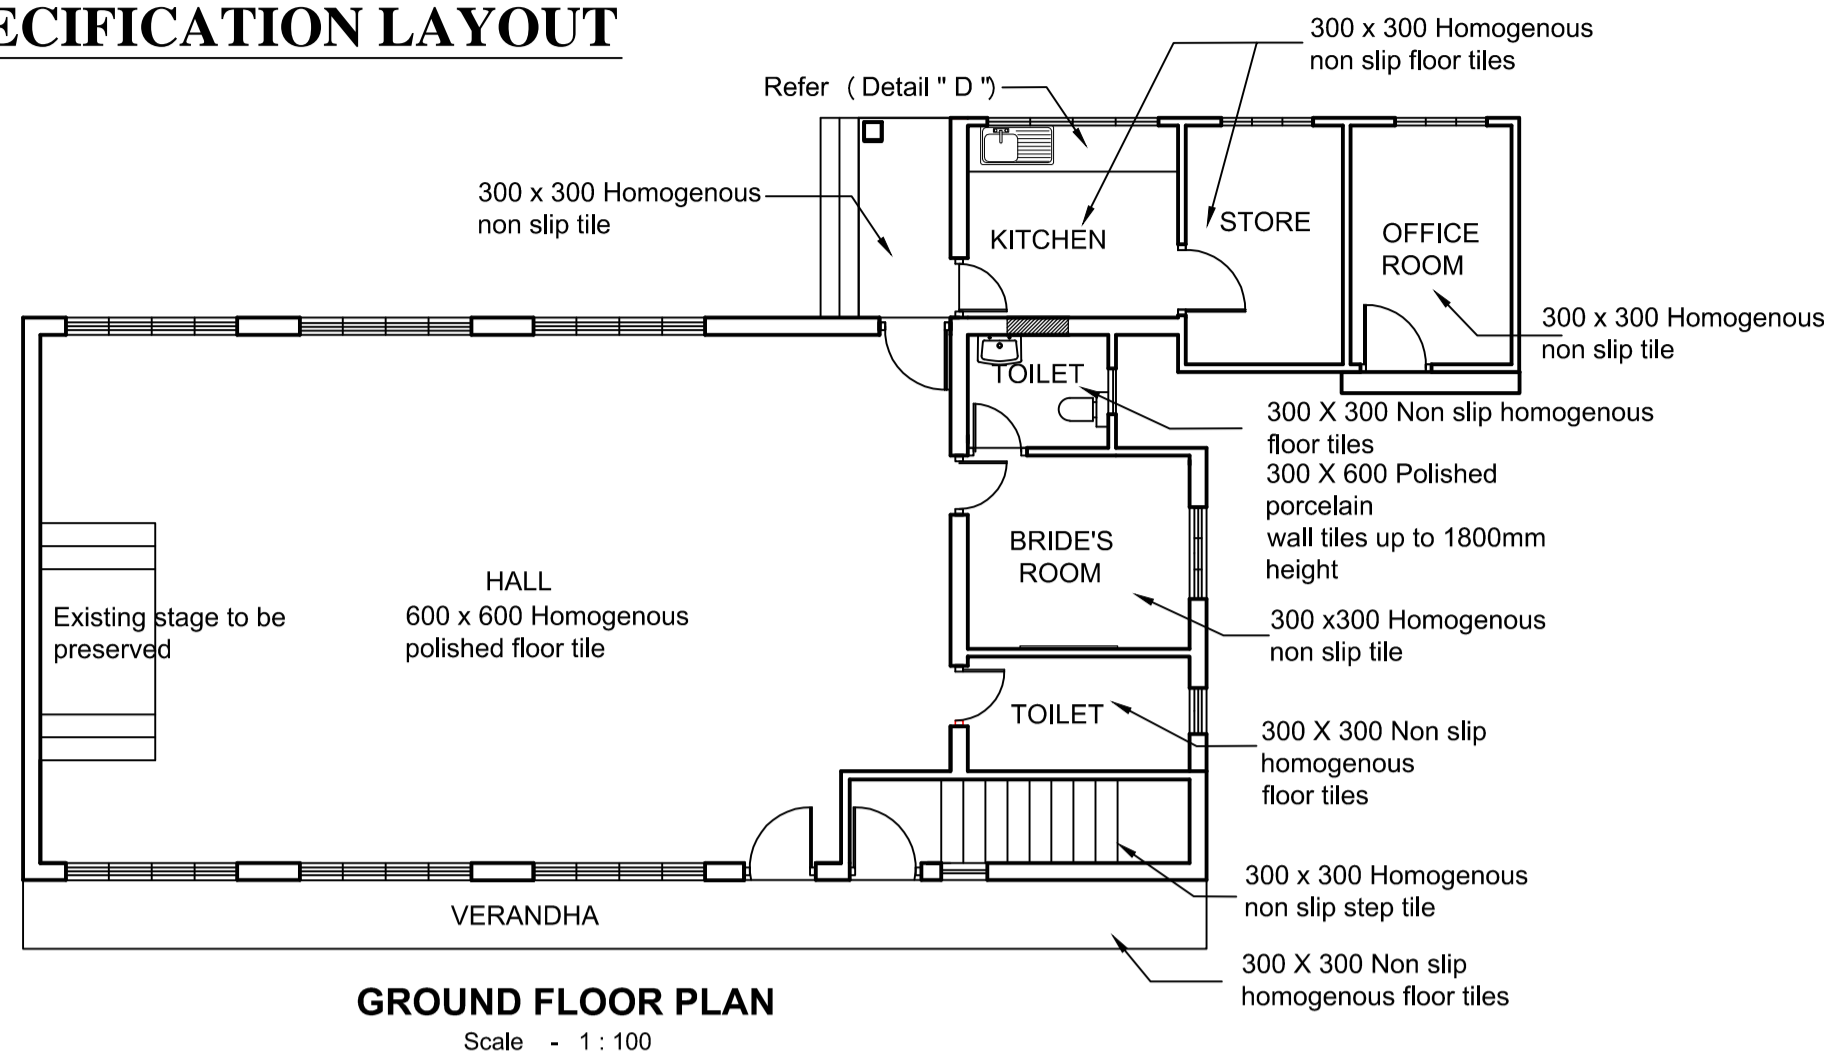

**DETAIL OF KITCHEN WORK TOP**


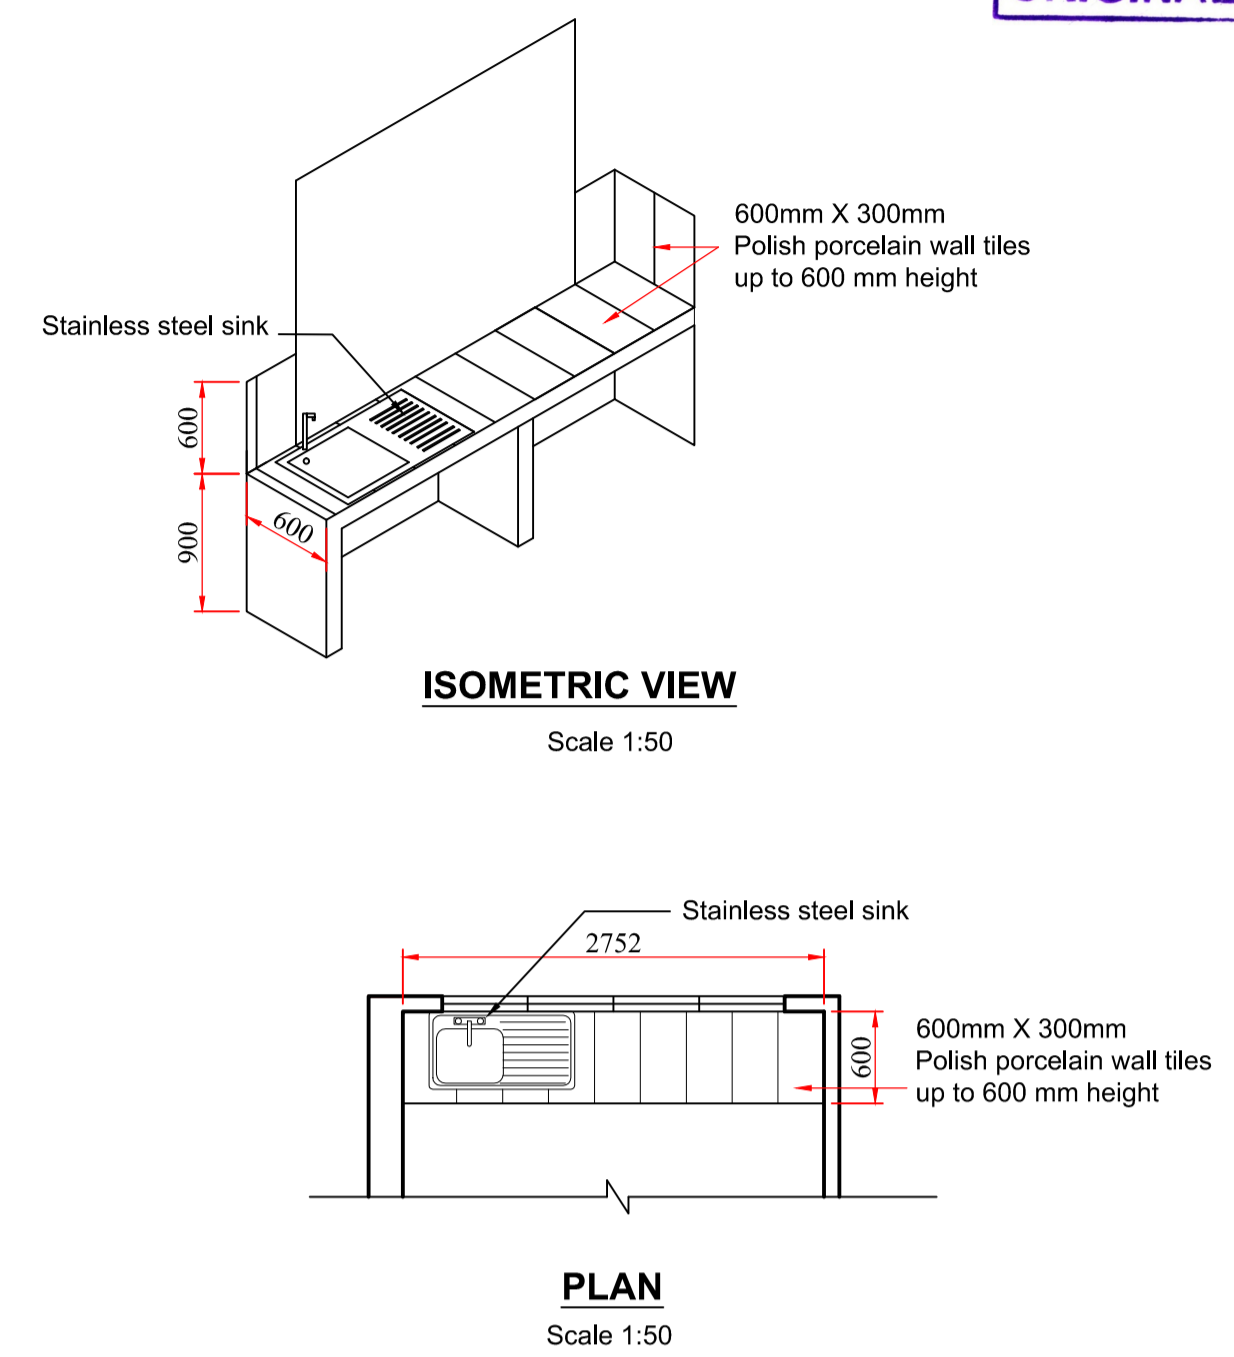


**ORIGINAL**

**NOTE**

1. This drawing is a property of the Architectural unit of the M.E's Department.
2. This drawing shall not be copied or altered without the consent of the Architect.
3. If any discrepancy or error is detected in the drawing it should be immediately notice of the Architect.
4. This drawing should be read in conjunction with structural drawings & all service drawings and any other drawings referred to in here.
5. Any construction work carried out not in accordance with the information in the drawing will be rejected by the Architect.
6. All dimensions to be checked at site prior to the construction.
7. Colours of fittings & tiles to be approved by the Architect.
8. Existing AI windows to be preserved do necessary repairs where necessary
9. All internal and external wall plastering to be repaired and finished with putty and paint.
10. All existing floor and wall tiles to be removed and replaced with new tiles.
11. Existing ceiling to be removed and replaced with new calcium silicate flat ceiling

**ELECTRICAL LAYOUT**

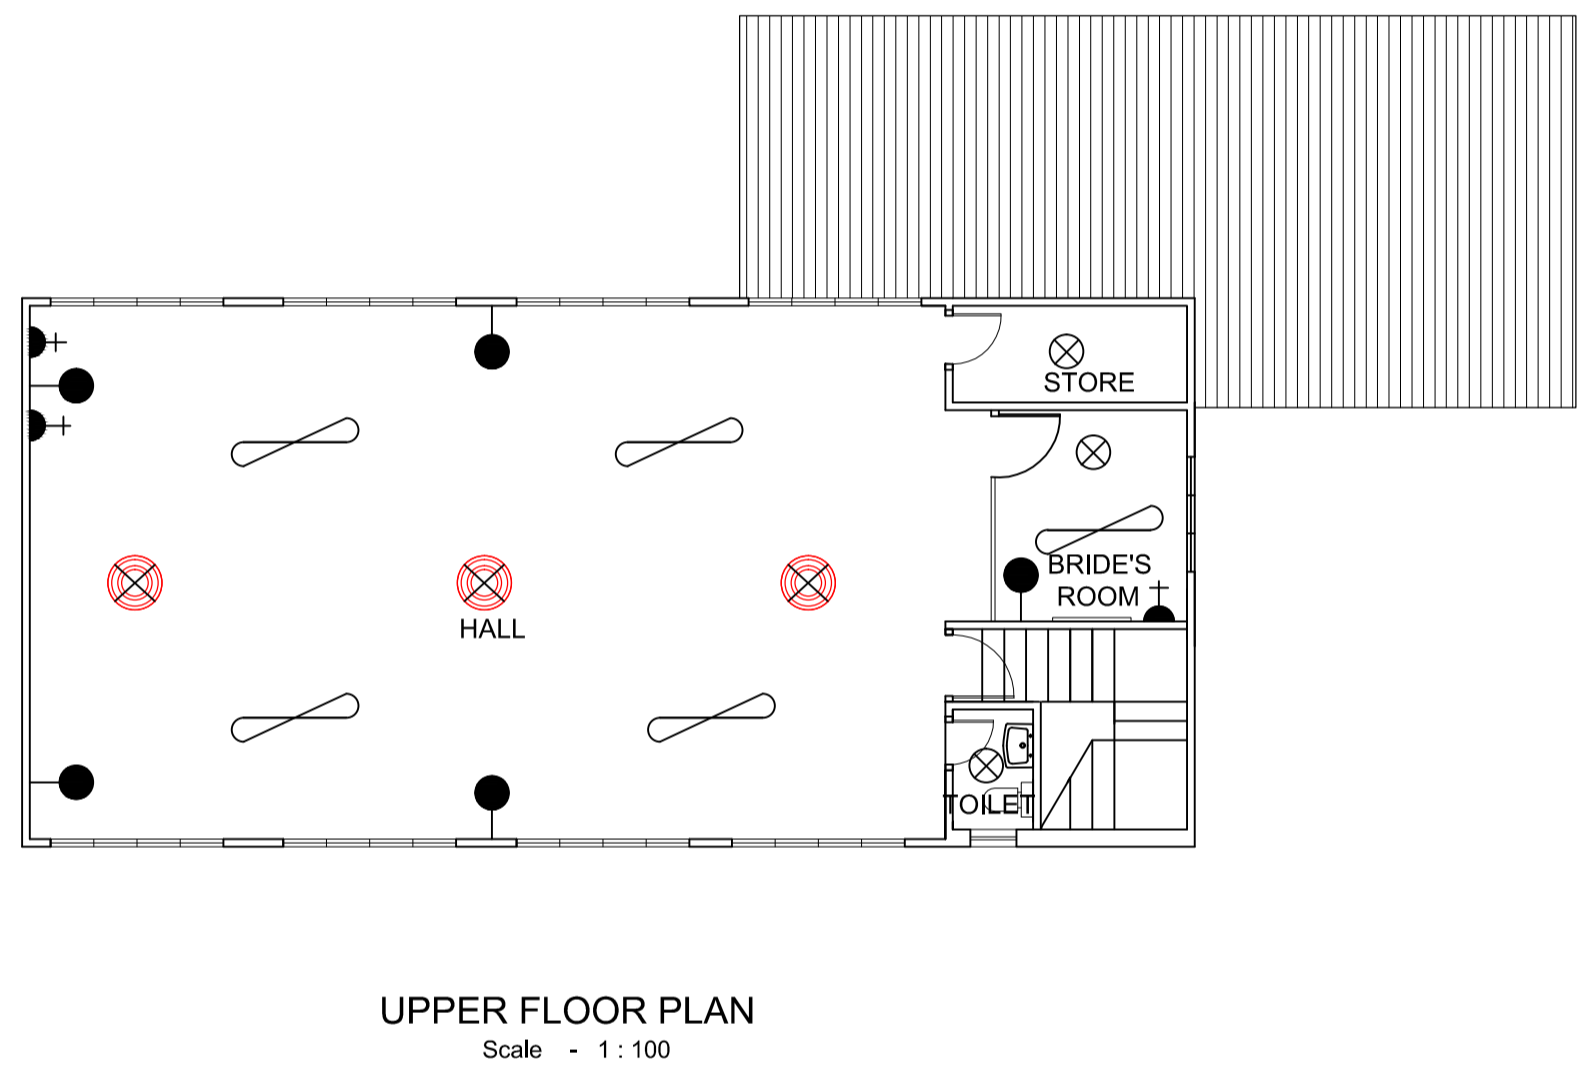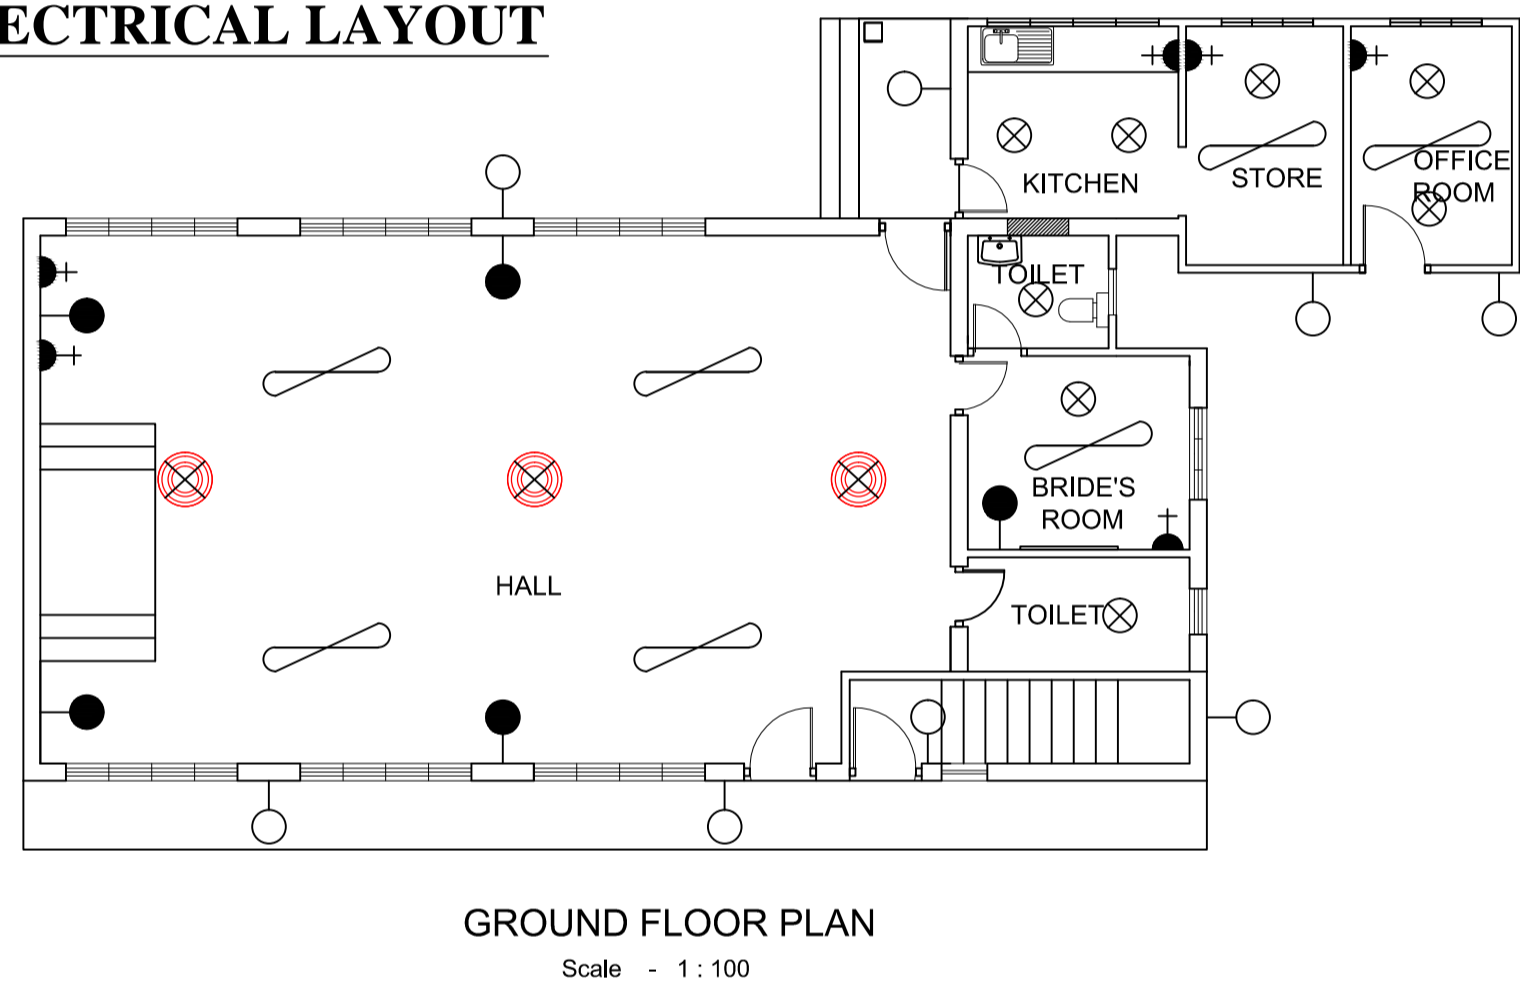

SYMBOLS OF ELECTRICAL ITEMS	
Description	Symbol
CEILING FAN	
OUTDOOR WALL BRACKET LAMPS	
INDOOR WALL BRACKET LAMPS	
PENDENT LAMPS	
CANDELAS LAMP	
13 A SOCKET OUTLET	
MIRROR LAMPS	








**COLOMBO MUNICIPAL COUNCIL  
MUNICIPAL ENGINEER'S DEPARTMENT**

**PROPOSED RENOVATIONS TO  
PARAKRAMA RECEPTION HALL  
AT GRANDPASS, COLOMBO 14.**

**FLOOR PLAN LAYOUTS, ELEVATIONS,  
SECTIONS & DETAILS.**

PROJECT ARCHITECT	E.G.L.MELLUGATHANNE		
STRUCTURAL ENGINEER	W.M.U.P.KUMARA		
SENIOR ARCHITECT	S.U.R.DOLAPHIILLA		
CHIEF ARCHITECT	M.C.L.FERNANDO		
DIRECTOR (Eng./ TDRS)	T.A.CHANDRAPALA		
D.M.C.(Eng.services.)	Y.SYLVESTER		

**GATE AND FENCE DETAIL**  
Scale :- 1:50

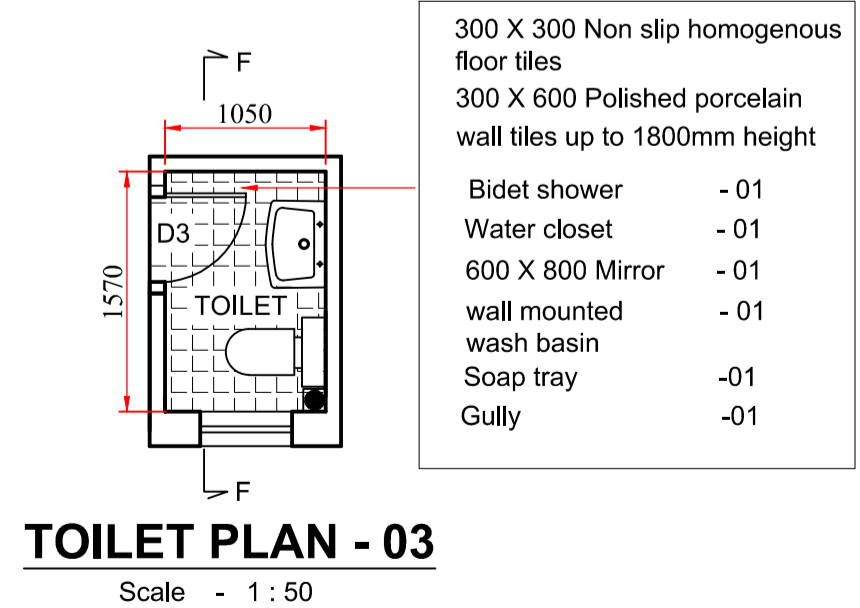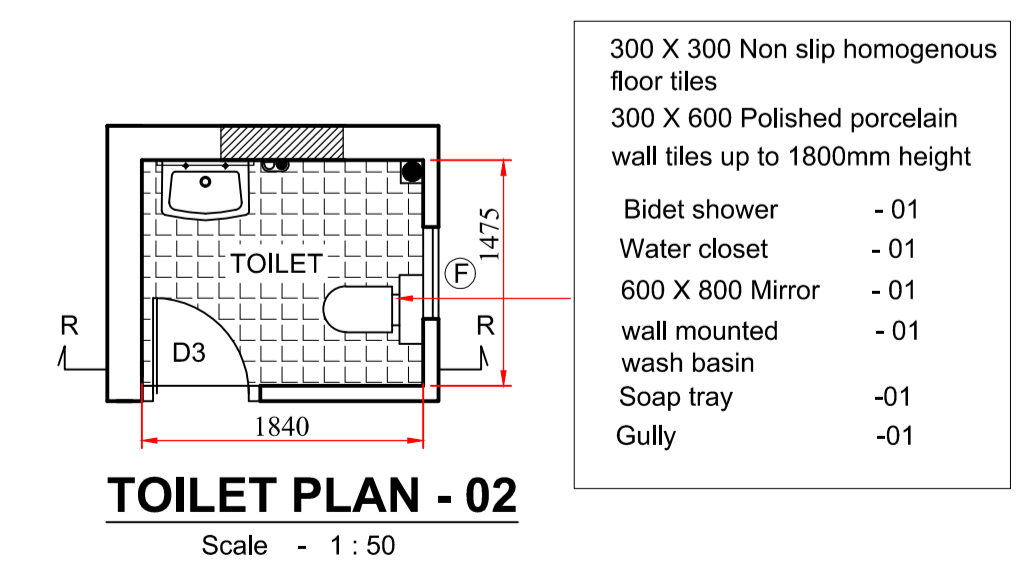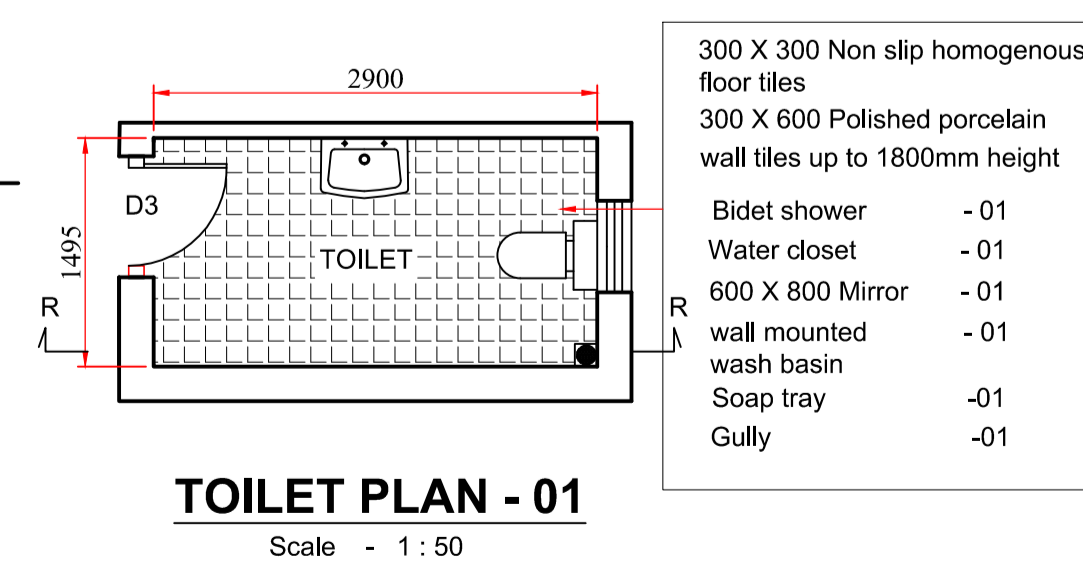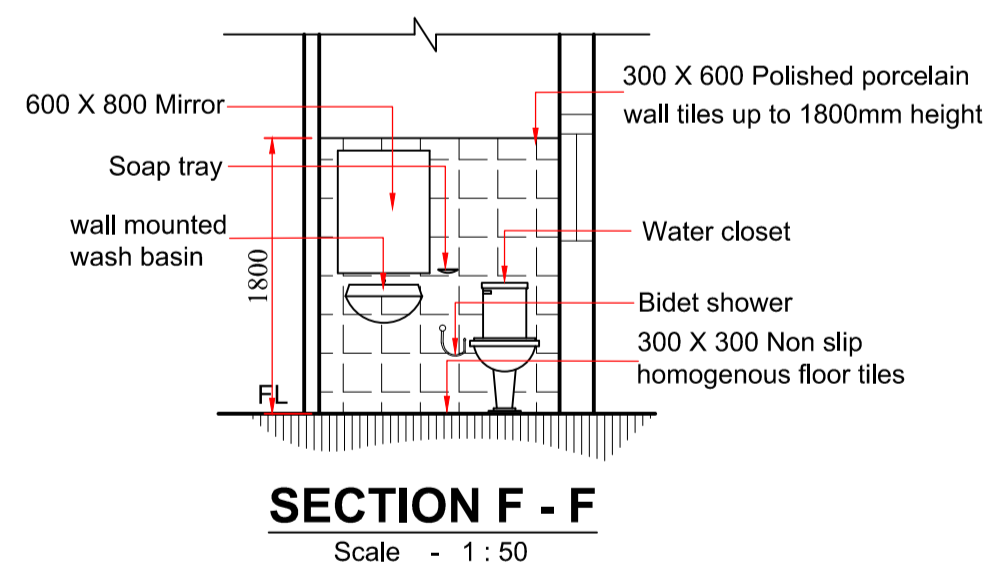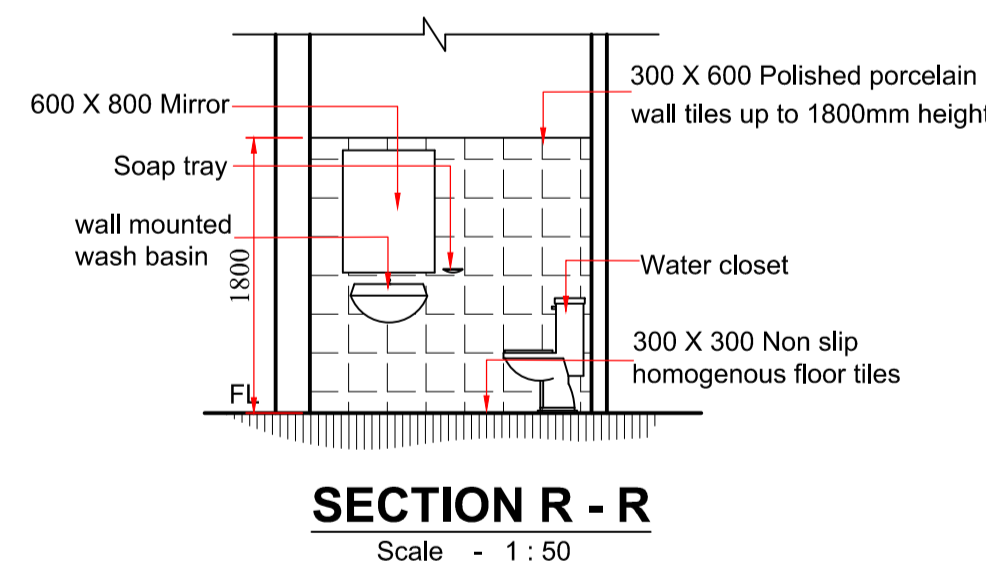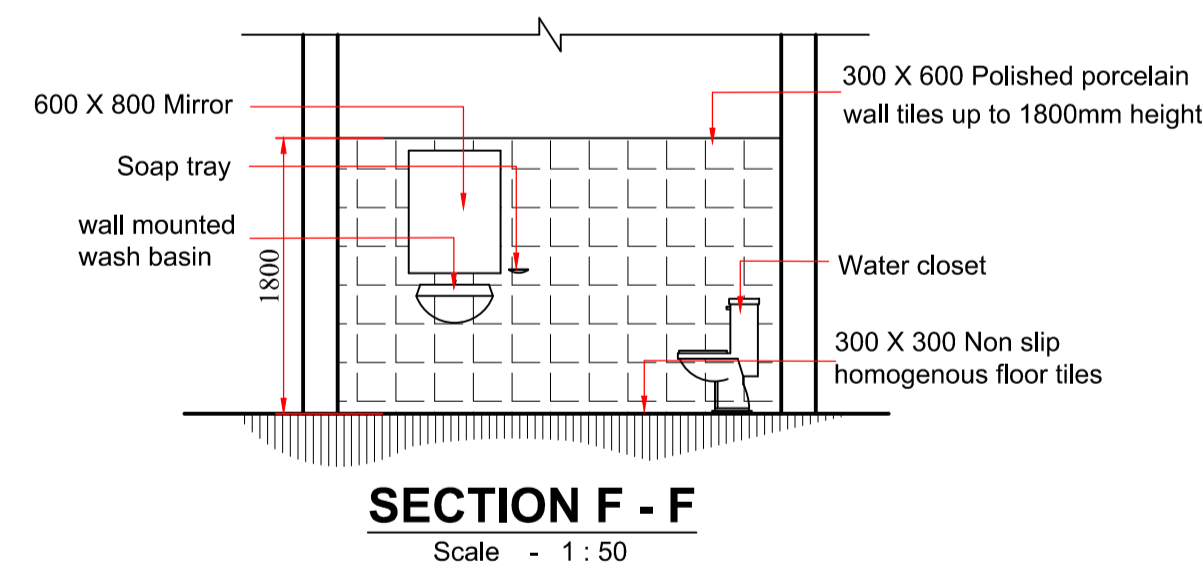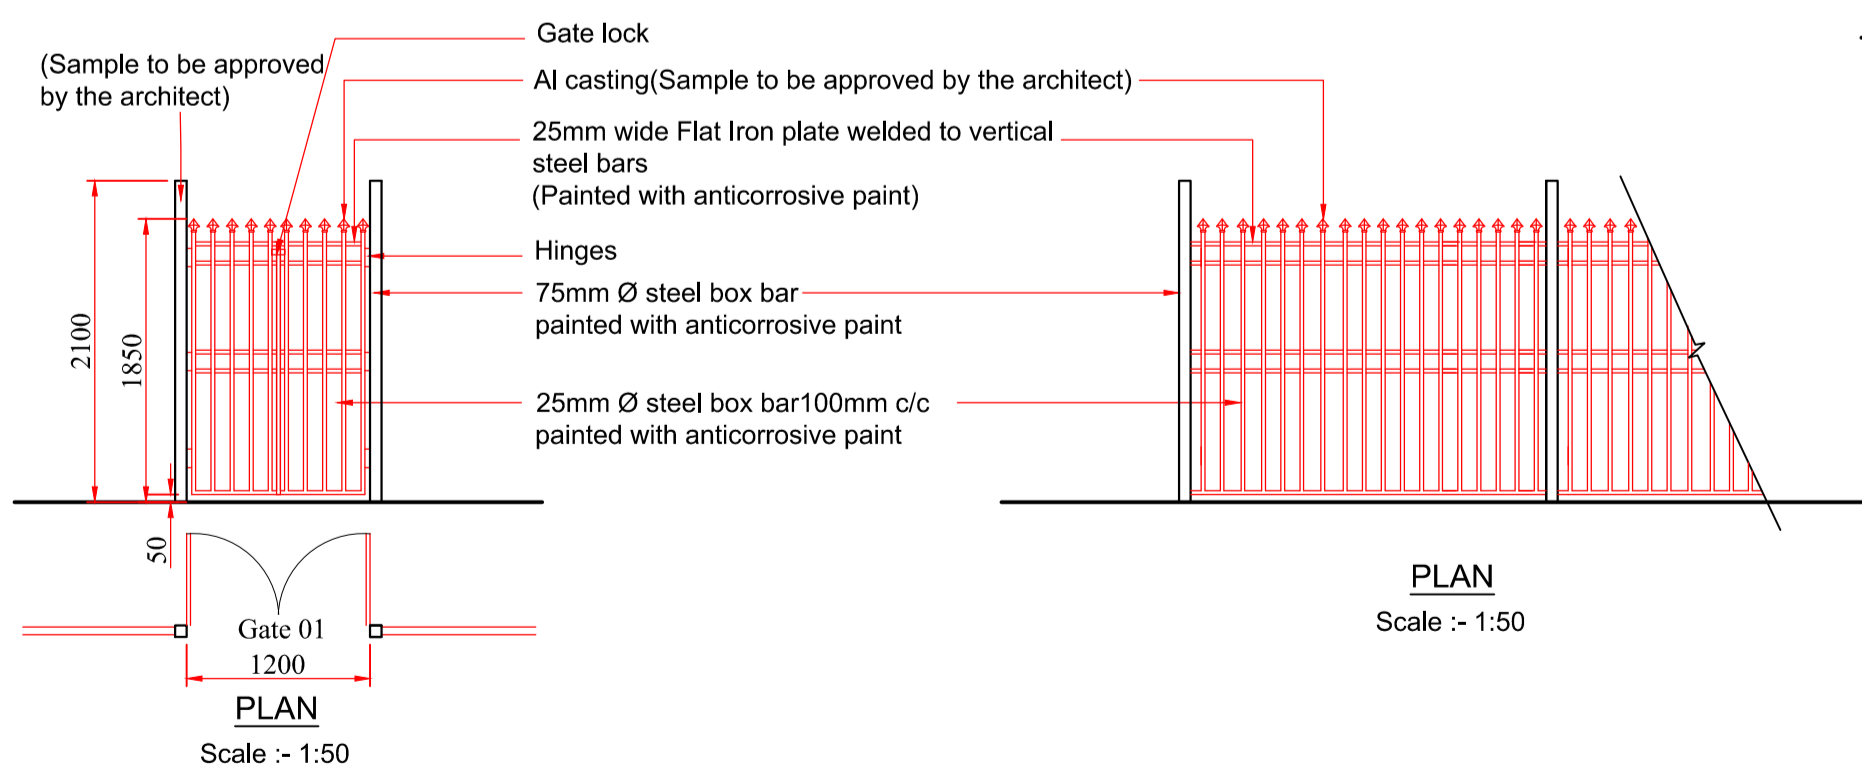

SCALE	DRAWN	CHECKED	
1:100 1:50	T.M.L.R.Thennakoon		Chavindu Senarathne
JOB NO.	SHEET NO.	D.O.A. ACT:	Chavindu Senarathne
2021/15	02/02	REVISION SUFFIX	
CLIENT DEPT./AUTHORIZED OFFICER'S NAME	DATE	DATE : 29-07-2021	
CLIENT SIGNATURE	DESIGNATION		