

**FRONT ELEVATION**

Scale - 1:50


**DUPLICATE**

JOB TITLE :- PROPOSED SUBSTATION BUILDING FOR CEYLON ELECTRICITY BOARD AT NO 104, SIR JAMES PEIRIS MAWATHA, COLOMBO - 02  
(To supply electricity for public health dept.buildings)



CLIENT DEP. APPROVAL	DATE
----------------------	------

SCALE 1:50 1:1000	DRAWN BY :K.A.P.Prabodhani DRAWING NO : 01/01	2021/16 JOB NO
-------------------------	--	-------------------

D.O.A.	PROJECT ARCHITECT.	SENIOR ARCHITECT	DIRECTOR ENG. (TD/RS)	D.M.C.(ENGINEERING)	DATE
					27-09-2021

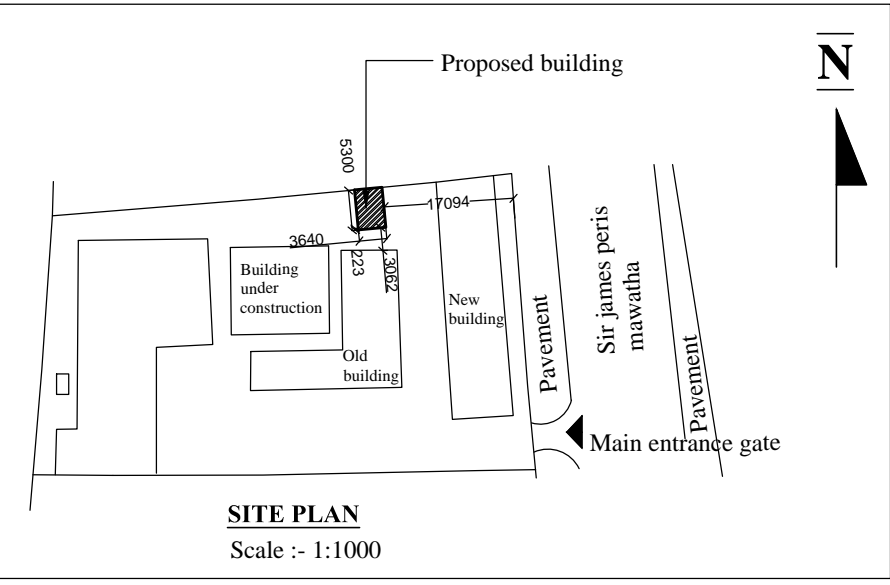

DOOR WINDOW SCHEDULE			
TYPE	SIZE	DESCRIPTION	NOS
D1	2700 x 2700	AL. FRAMED AL. DOOR WITH AL. LOUVERS ON TOP	01
D2	1200 x 2700	AL. FRAMED AL. DOOR WITH AL. LOUVERS ON TOP	01
L	1000 x 800	AL. LOUVER WINDOW	04

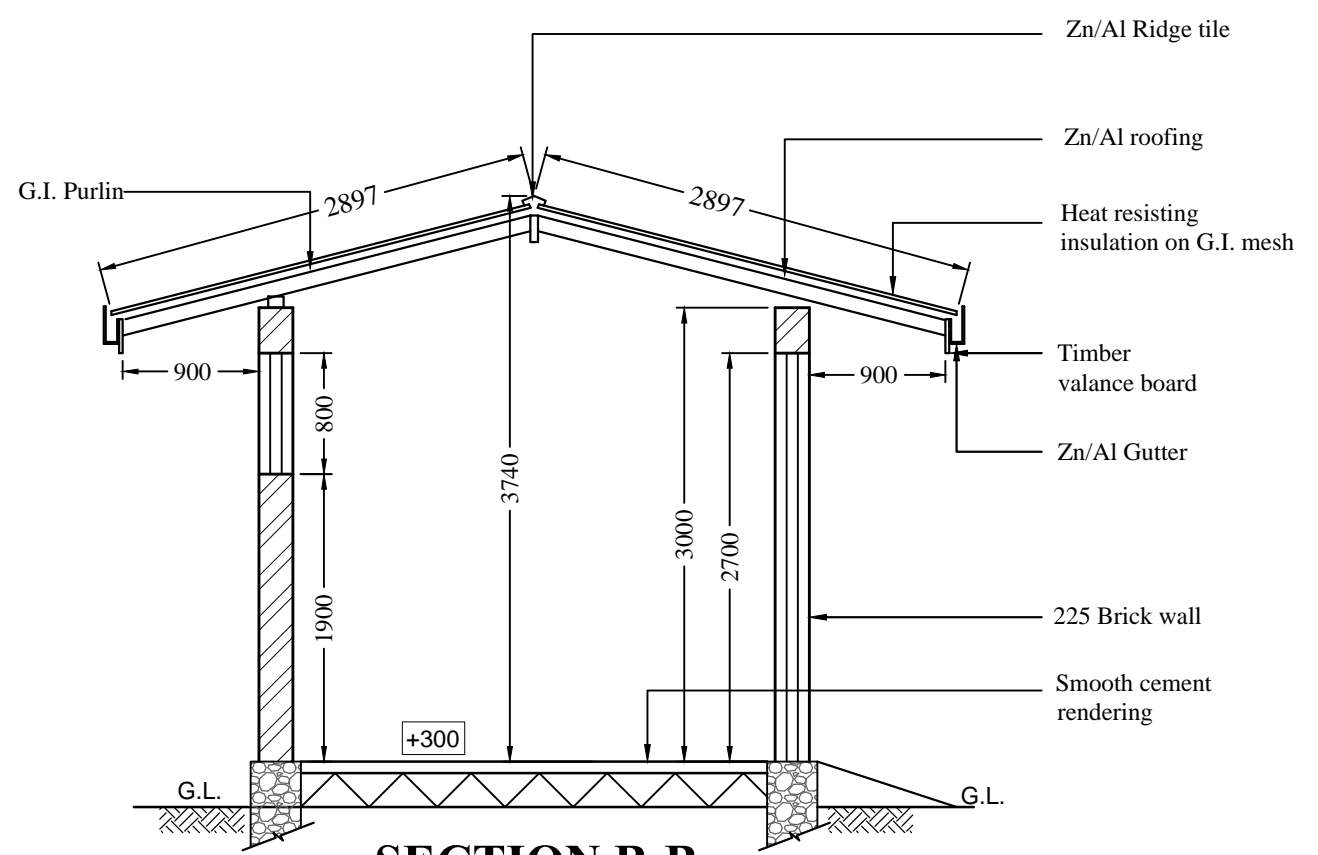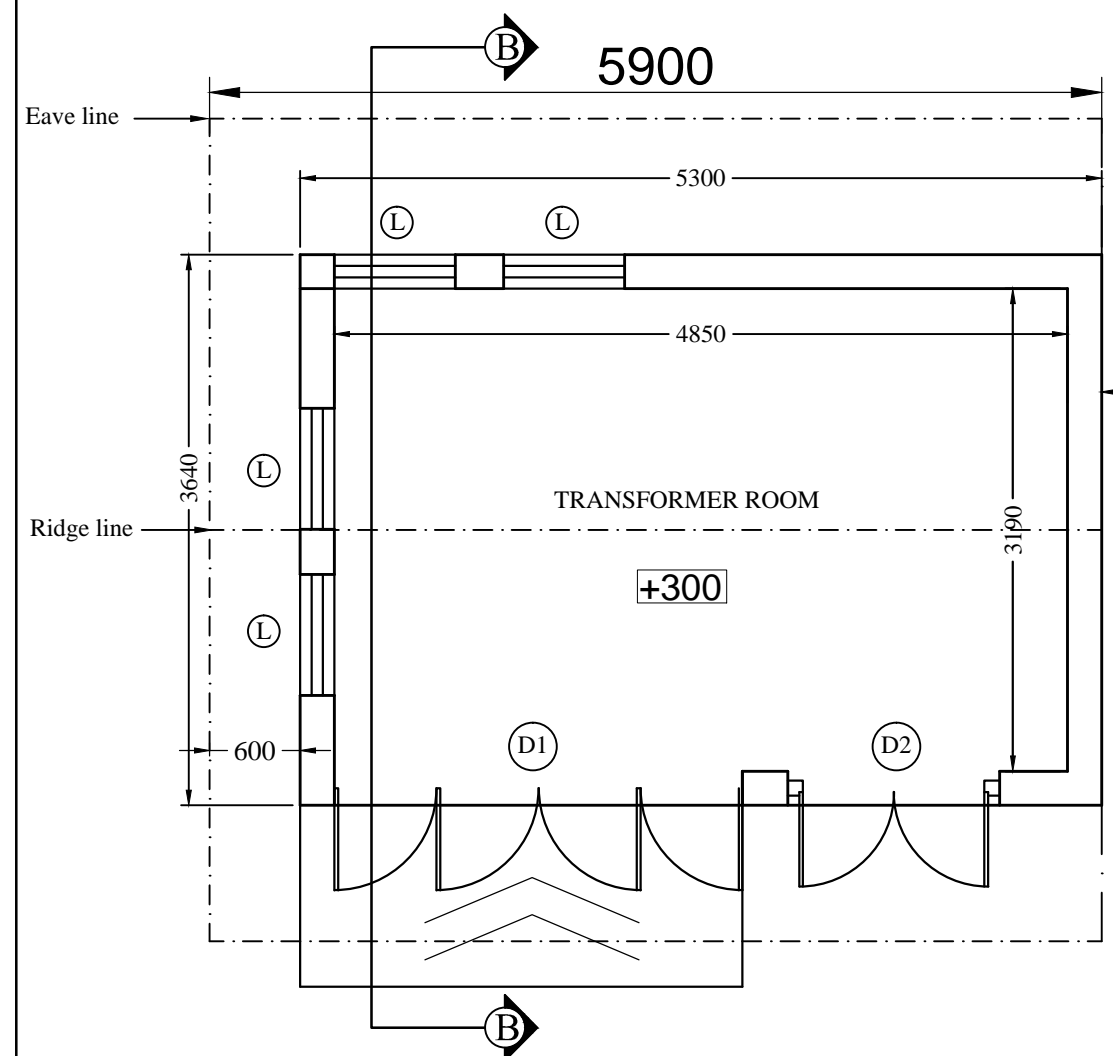

Part of existing boundary wall to be demolished